


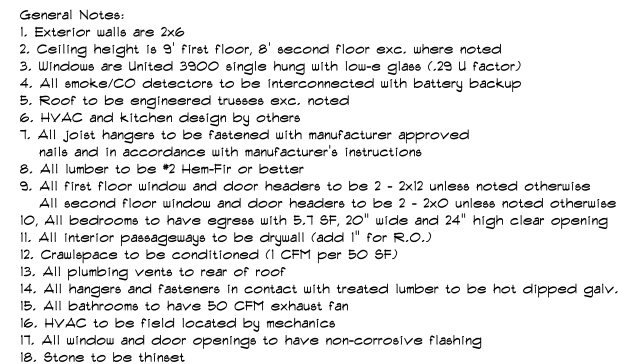


Insulation Schedule
Crawlspace Walls - R10
House Walls - R23
Ceiling - R38

SF Calculations
First Floor - 1997
Second Floor - 911 unfinished
Garage - 624
Front Porch - 240
Rear Porch - 128


OPENING SCHEDULE	
PRODUCT CODE	R.O. SIZE
6068 sliding door	R.O. 6'-0" x 6'-8"
2832	R.O. 2'-8" x 3'-2"
2850-3	R.O. 8'-0" x 5'-0"
3050-2	R.O. 6'-0" x 5'-0"
3050-3	R.O. 9'-0" x 5'-0"
3050	R.O. 3'-0" x 5'-0"
3060	R.O. 3'-0" x 6'-0"
Bedroom 2 window	R.O. 1'-0" x 1'-0"
4040 fixed	R.O. 4'-0" x 4'-0"

Builder to verify rough openings
before starting construction

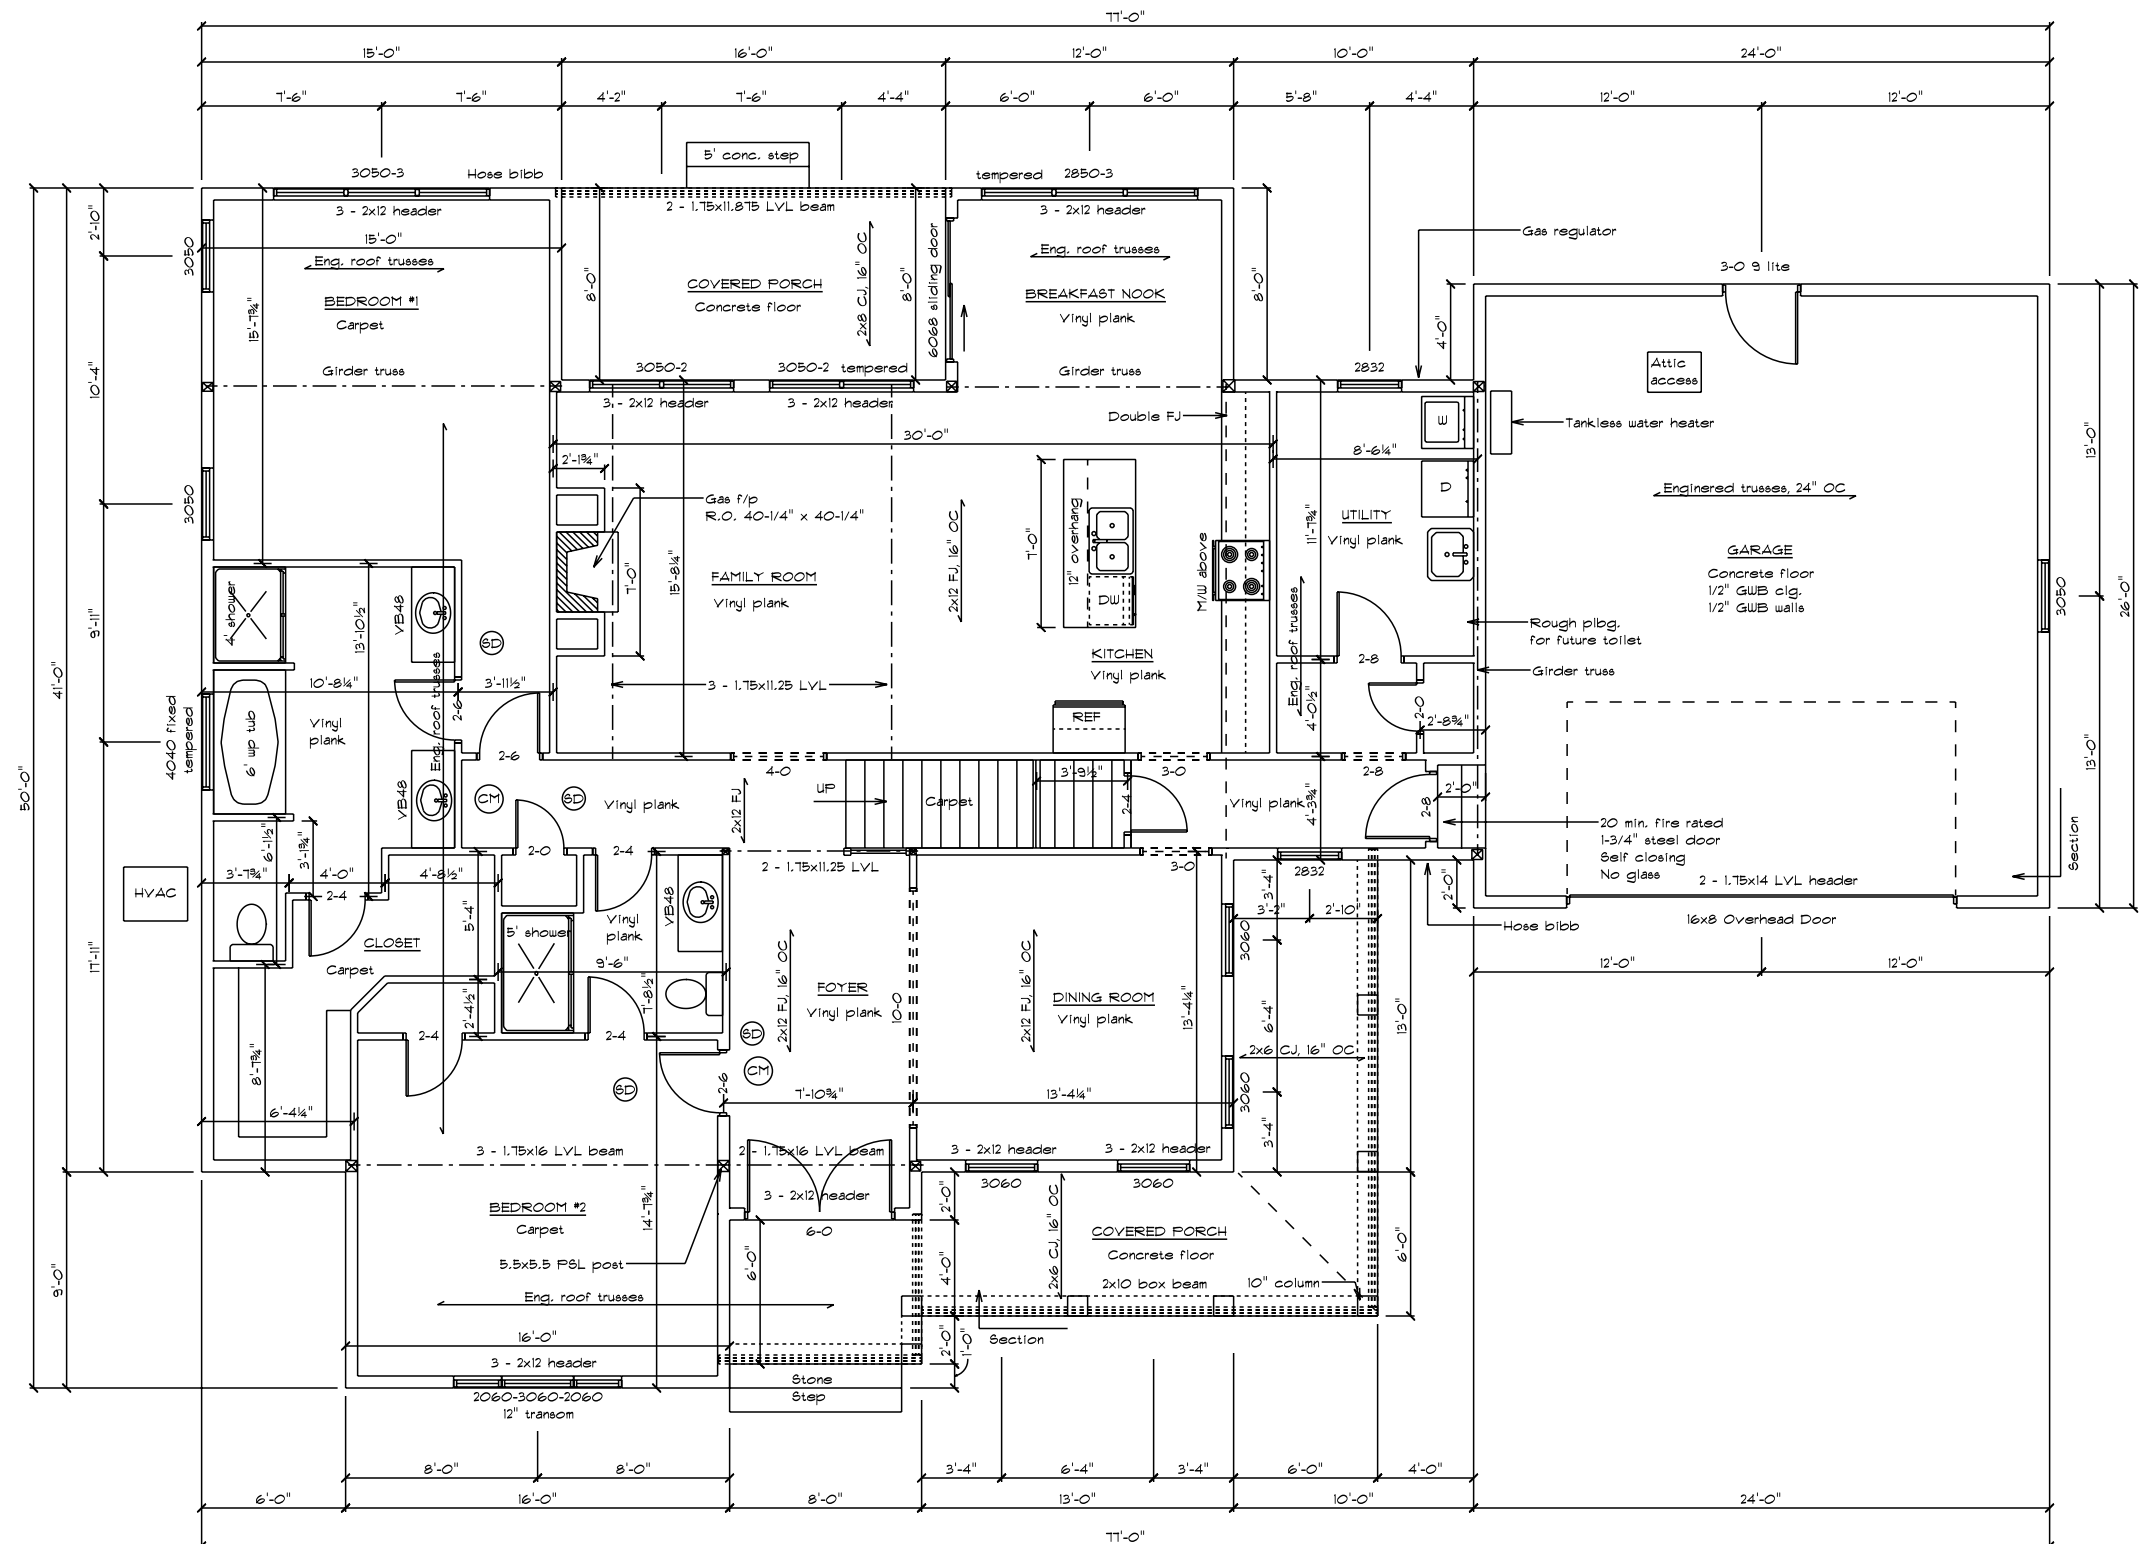

Builder to verify rough openings
before starting construction

Drawing Number 2

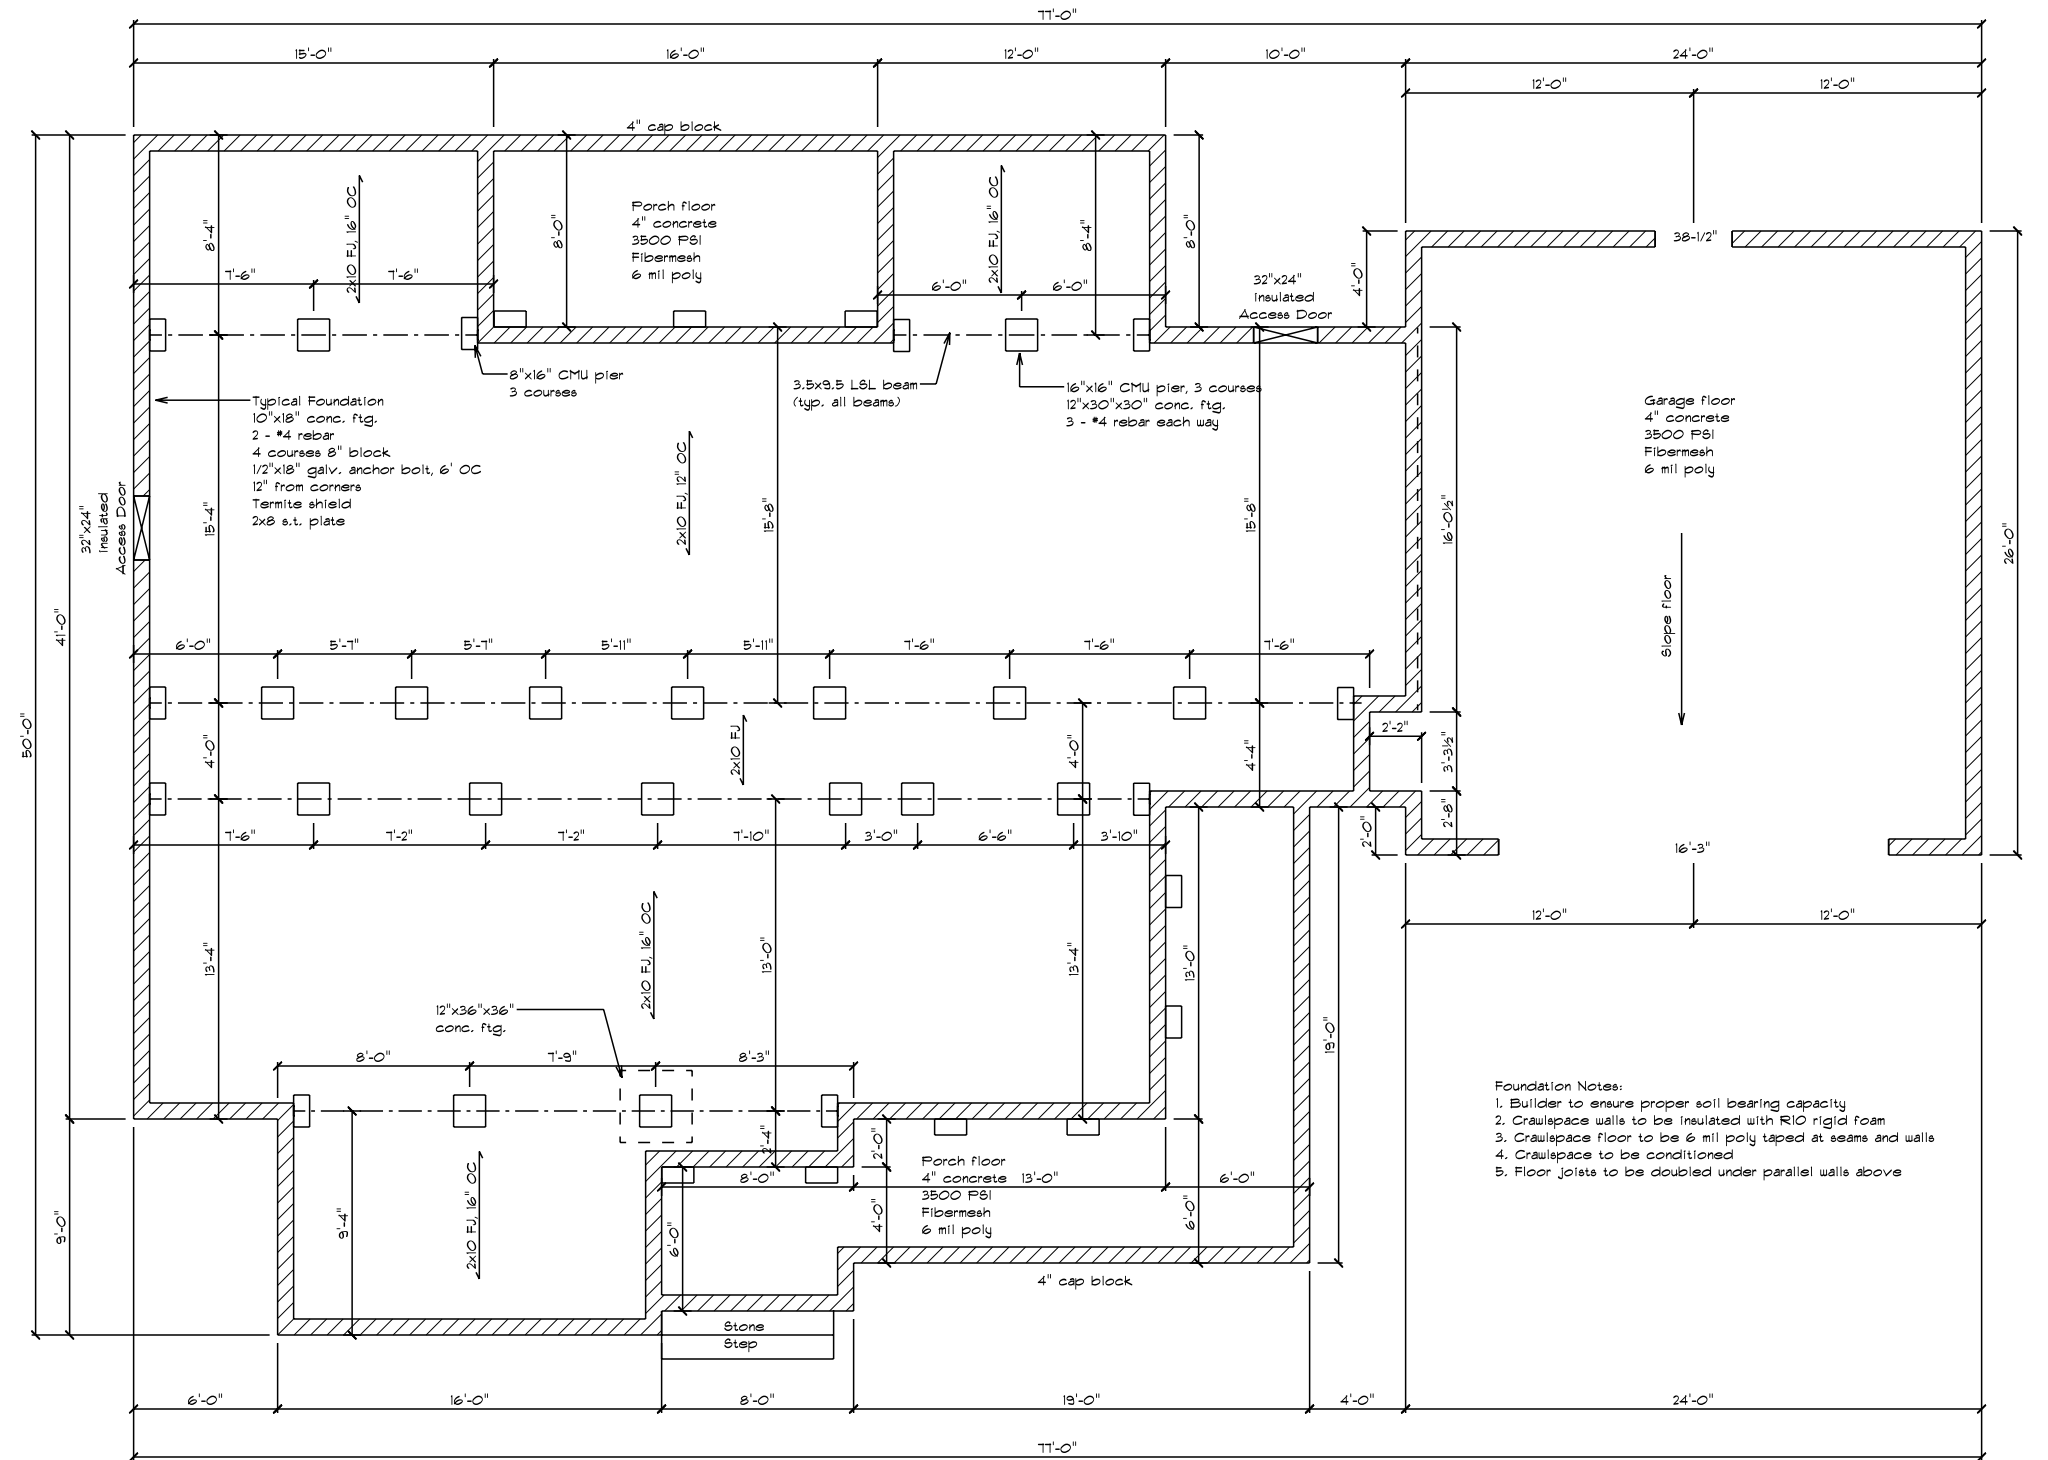

Home Design Plus, Inc.

8048 Hidden Meadow Lane
Greenwood, DE 19950 302-424-3998

Disclaimers

Owner/Contractor assumes responsibility of building to applicable codes
Designer is not responsible for mistakes found after construction is begun
Designer is not a licensed architect
No warranty is expressed or implied

Contractor

Accessible Home Builders

Alexander

Foundation Plan

Scale 1/4"=1'-0"

6/25/2019

Approved

Drawn By John Warfel

Revised

Drawing Number 3



Front Elevation



Left Elevation



Rear Elevation



Right Elevation

Home Design Plus, Inc.

8048 Hidden Meadow Lane
Greenwood, DE 19950 302-424-3998

Disclaimers

Owner/Contractor assumes responsibility of building to applicable codes
Designer is not responsible for mistakes found after construction is begun
Designer is not a licensed architect
No warranty is expressed or implied

Contractor

Accessible Home Builders

Alexander

Elevations

Scale 1/4"=1'-0"

6/25/2019




Approved

Drawn By John Warfel

Revised

Drawing Number

4

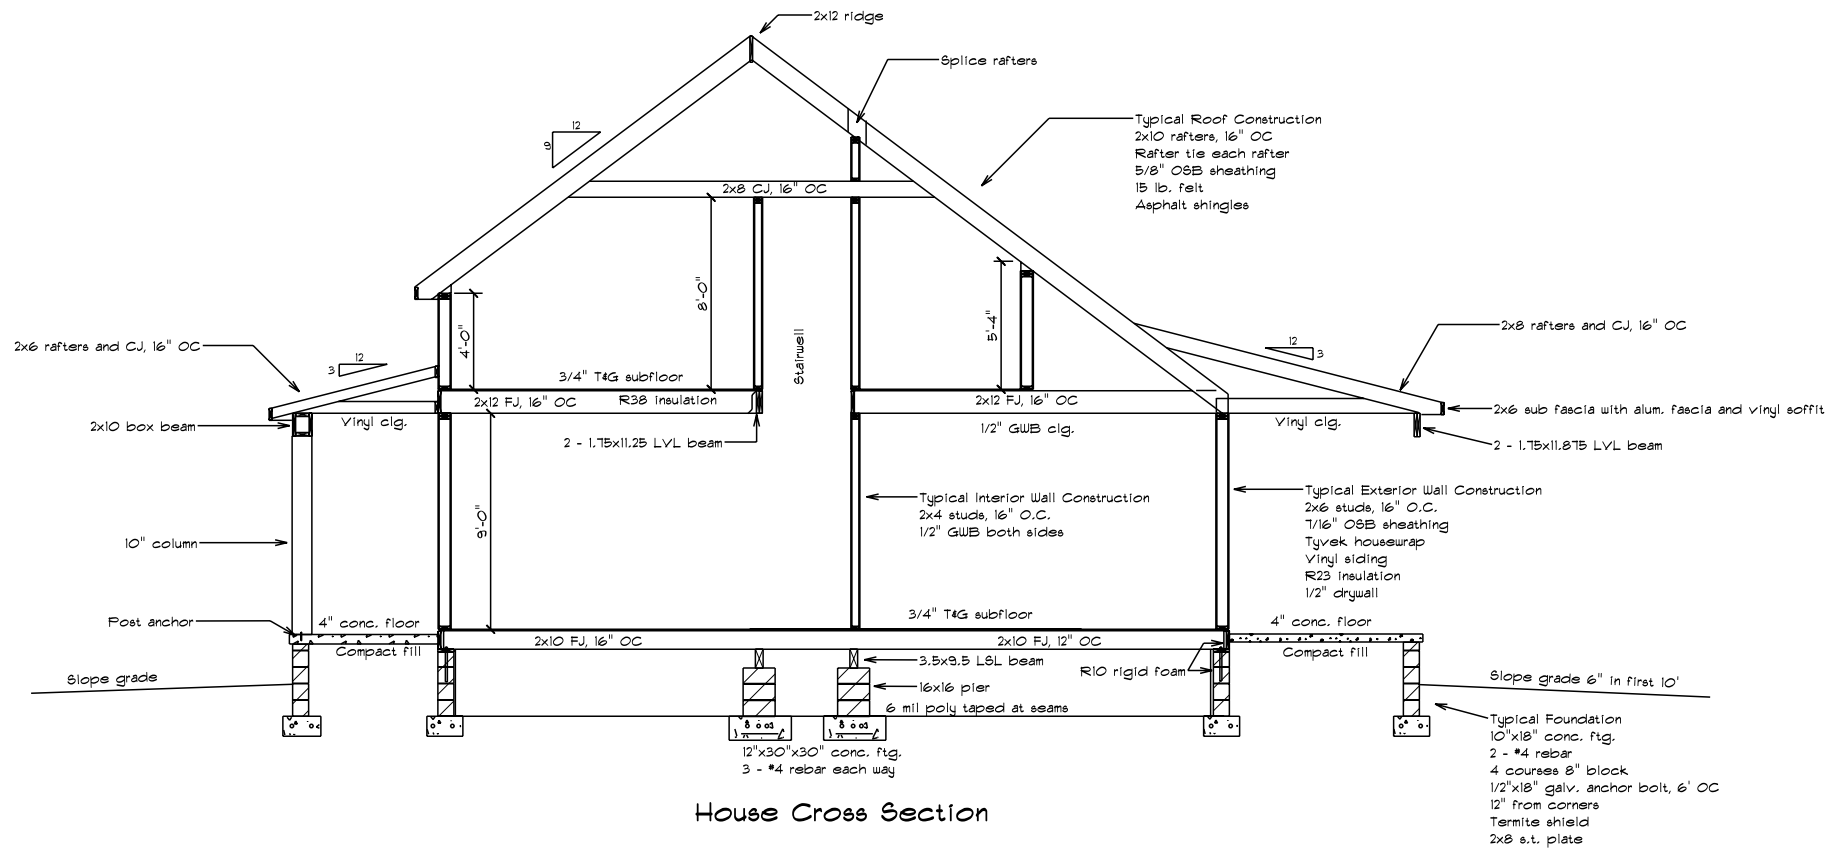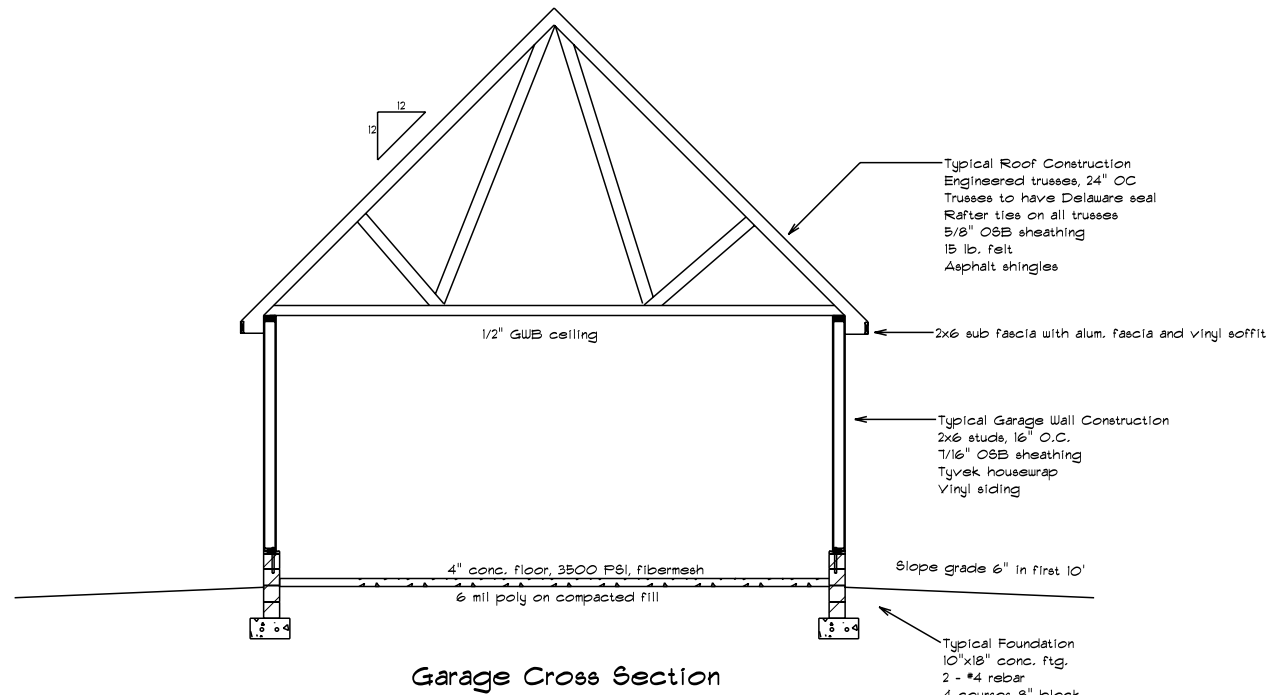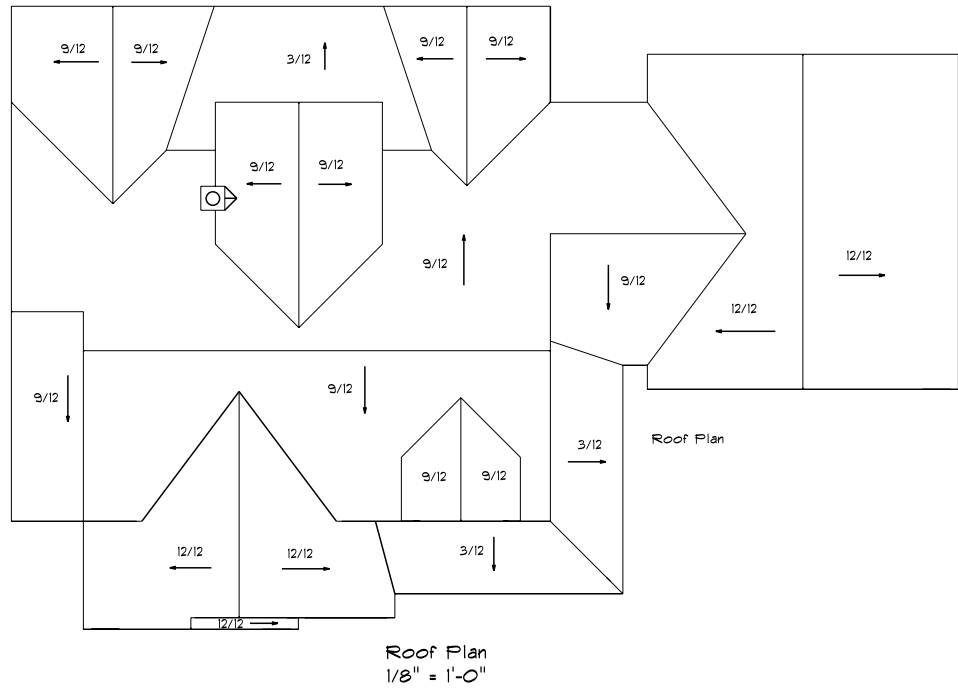

Home Design Plus, Inc.

8048 Hidden Meadow Lane
Greenwood, DE 19950 302-424-3998

Disclaimers

Owner/Contractor assumes responsibility of building to applicable codes
Designer is not responsible for mistakes found after construction is begun
Designer is not a licensed architect
No warranty is expressed or implied

Contractor

Accessible Home Builders

Alexander

Cross Sections/Roof Plan

Scale 1/4"=1'-0"

 
6/25/2019

Approved

Drawn By John Warfel

Revised

Drawing Number 5

ELECTRICAL LEGEND	
ELECTRICAL	SYMBOL
ceiling fan	
ceiling fan/light	
exhaust fan/light	
recessed light	
carbon monoxide detector	
smoke detector	
light	
outlet	
outlet gfi	

All electrical work to be per NEC

